


Current Owner:
Town of Groton
Board of Education
1300 Flanders Road
Mystic, CT 06355

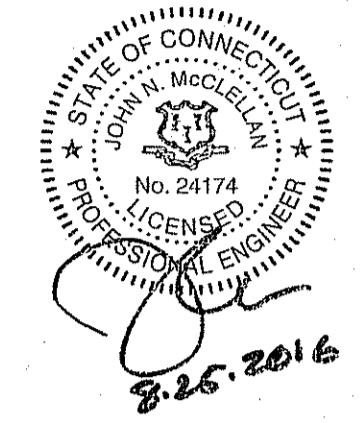

ISSUED FOR
TOWN OF GROTON
LAND USE
APPLICATION

Aquarion Water
Company
600 Lindley Street
Bridgeport, CT

Fieldcrest Water
Storage Tank
(115 Oslo Street)
Groton, Connecticut

Parcel ID:
271017012410 E
August 2016

VERIFY SCALE
BAR IS 1 INCH ON
ORIGINAL DRAWING
IF NOT ONE INCH ON
THIS SHEET, ADJUST
SCALES ACCORDINGLY



6/13/16	ADDRESS PLANNING DEPT. COMMENTS	
3/24/16	ADDRESS PLANNING DEPT. COMMENTS	
2/3/16	ADDRESS OWNER COMMENTS	
Mark	Date	Description
PROJECT NO.	A100018	
FILE:	Sheet3and4.dwg	
DRAWN BY:		
CHECKED:	LJE, JNM	
APPROVED BY:		

PROPOSED CONDITIONS
SITE PLAN

SCALE: 1"=30'

SHEET 3

6/13/2016 8:55am By: jmm
Last Saved: AutoCAD LT 2011
File: J:\A\A000_AWC\18 - Fieldcrest Alternatives Analysis\Drawings\FINAL PERMIT_Sheet3and4.dwg

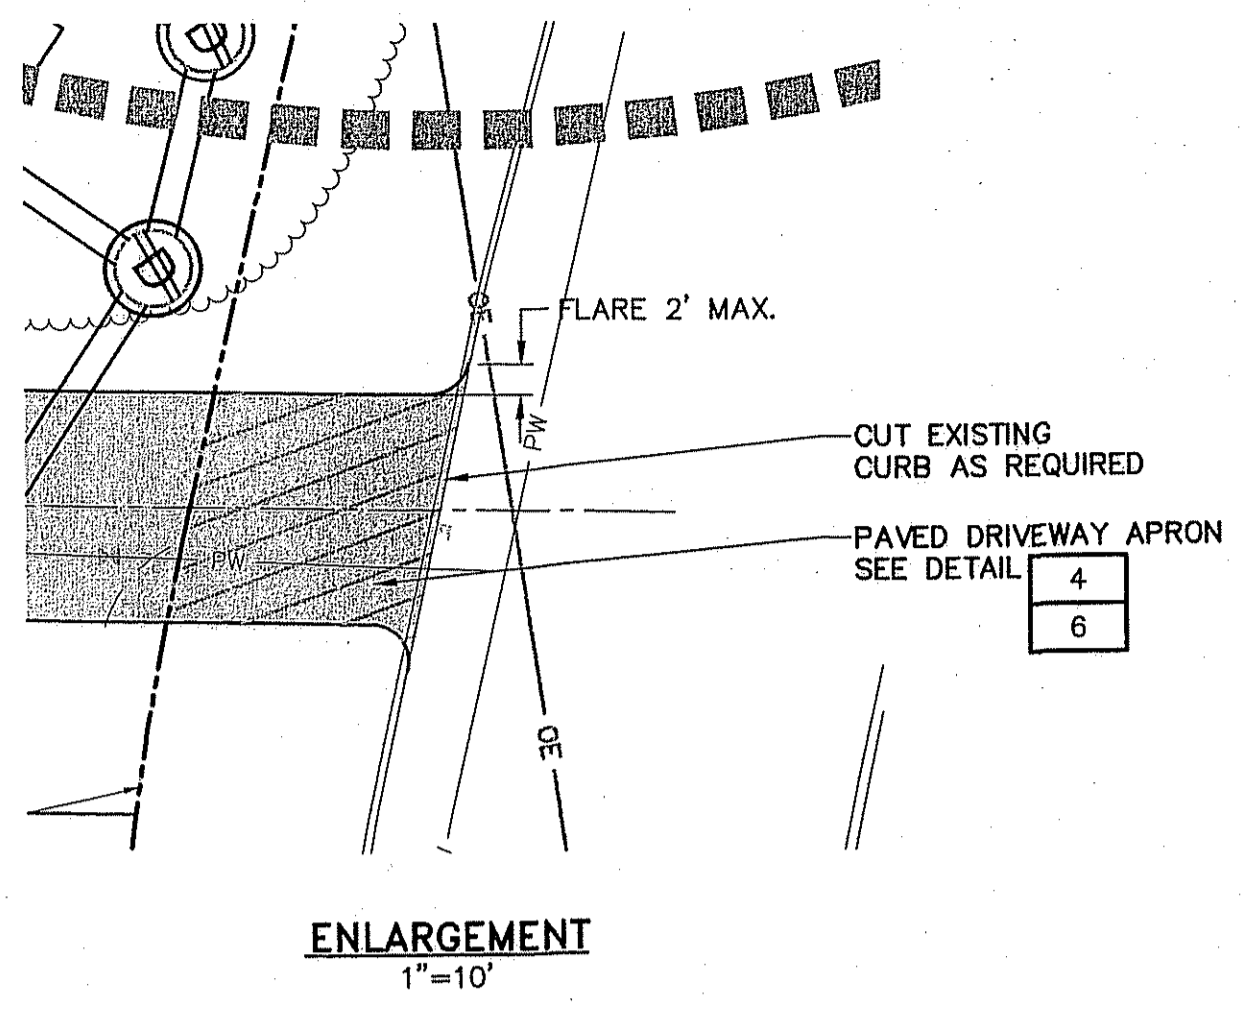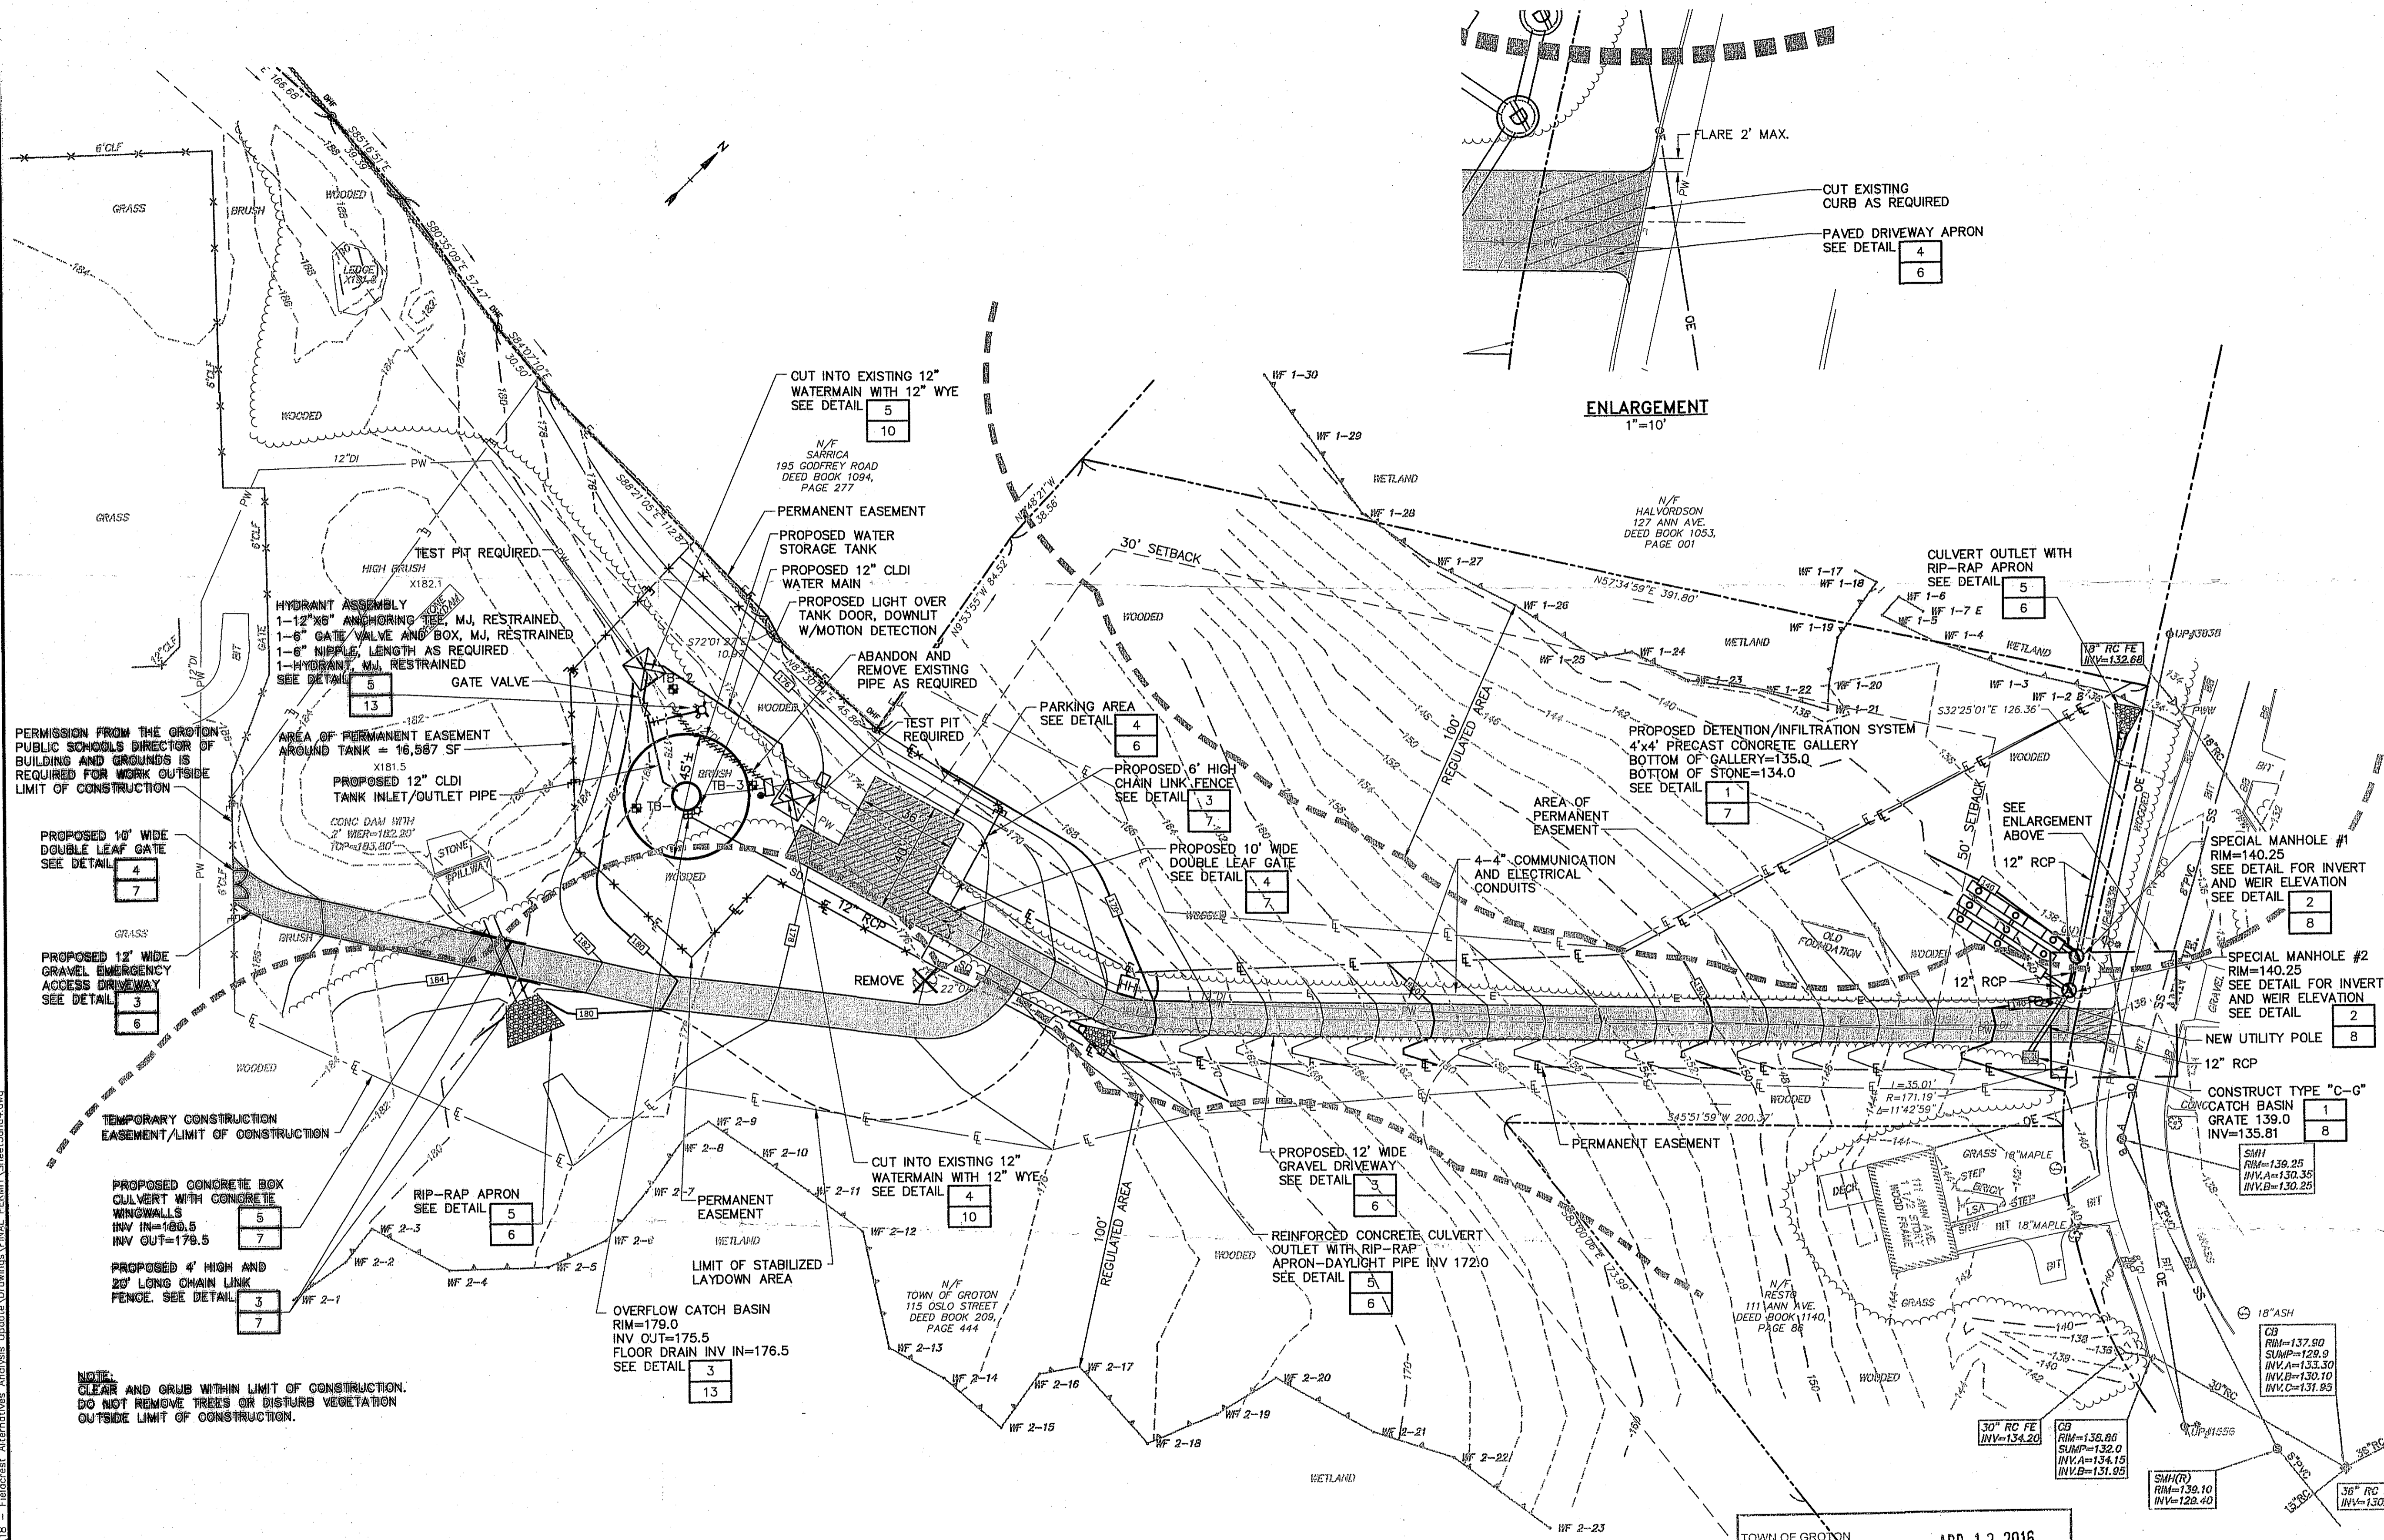

NOTE:
AQUARION WATER COMPANY IS RESPONSIBLE
FOR THE MAINTENANCE AND REPAIR OF THE
DETENTION/INFILTRATION SYSTEM AND ITS
ASSOCIATED DRAINAGE SYSTEM.

TOWN OF GROTON
PLANNING COMMISSION
APPROVAL GRANTED DATE APR 12 2016
[Signature]
UNLESS OTHERWISE APPROVED, ALL WORK SHALL BE COMPLETED BY
APR 12 2021

